

REFINERY AREA	UNIT NO.	DESCRIPTION	SITE PLAN
UPPER FIELD	TK-378	GASOLINE	208
DISMANTLING COST			Low Cost 50 - 200 MM USD

REFINERY AREA	UNIT NO.	DESCRIPTION	SITE PLAN
BUILDINGS AND AREAS	LAGUNA NEGRA		207 A&B
BUILDINGS AND AREAS	POB		207 A&B
BUILDINGS AND AREAS	GARAGE		207 A&B
UPPER FIELD	TK-774	SPHERE BUTANE TANK (NC4)	207 A&B
UPPER FIELD	TK-565	NAPHTA / HSR	207 A&B
UPPER FIELD	TK-497	GASOLINE	207 A&B
UPPER FIELD	TK-480	LEADED SLOP/SLUDGE	207 A&B
DISMANTLING COST			Low Cost 50 - 200 MM USD

REFINERY AREA	UNIT NO.	DESCRIPTION	SITE PLAN
UPPER FIELD	D-801	PROPANE BULLET DRUM (O.O.S Sinds 2006, Last Strapped Feb-1985)	205
UPPER FIELD	D-802	PROPANE BULLET DRUM (O.O.S Sinds 2006, Last Strapped Feb-1985)	205
UPPER FIELD	D-803	PROPANE BULLET DRUM (O.O.S Sinds 2006, Last Strapped Aug-1994)	205
UPPER FIELD	D-804	PROPANE BULLET DRUM (O.O.S Sinds 2006, Last Strapped Feb-1984)	205
UPPER FIELD	D-806	PROPANE BULLET DRUM (O.O.S Sinds 2006, Last Strapped Feb-1988)	205
UPPER FIELD	D-807	PROPANE BULLET DRUM (O.O.S Sinds 2006, Last Strapped Feb-1988)	205
UPPER FIELD	TK-368	JET FUEL (O.O.S Sinds 2006, Last Strapped Aug-1992)	205
UPPER FIELD	TK-541	LOW SULFUR DIESEL (Recommendation to Refuelate, Last Strapped Feb-1999)	205
UPPER FIELD	TK-458	GASOL (O.O.S, Restricted Filling Height 15 Feet, Last Strapped Feb-1999)	205
DISMANTLING COST			Low Cost 50 - 200 MM USD



REFINERY AREA	UNIT NO.	DESCRIPTION	SITE PLAN
NORTH AREA COMPLEX	TKAR	TAR COOLER / UNIT 77	212
NORTH AREA COMPLEX	H1AR	HYDROGEN PLANT NO.1	212
NORTH AREA COMPLEX	H2AR	HYDROGEN PLANT NO.2	212
NORTH AREA COMPLEX	H3AR	HYDROGEN PLANT NO.3	212
POWER HOUSE 1	TG-3	TURBO GENERATOR NO. 3	212
POWER HOUSE 1	TG-4	TURBO GENERATOR NO. 4	212
POWER HOUSE 1	TG-9	TURBO GENERATOR NO. 9	212
POWER HOUSE 1	TG-10	TURBO GENERATOR NO. 10	212
POWER HOUSE 1	GT-1	GAS TURBINE NO. 1	212
POWER HOUSE 1	GT-2	GAS TURBINE NO. 2	212
POWER HOUSE 1	DS1AR	DESALINATION PLANT NO.1	212
POWER HOUSE 1	DS2AR	DESALINATION PLANT NO.2	212
POWER HOUSE 1	JOY-1	AIR COMPRESSOR NO.1	212
POWER HOUSE 1	JOY-2	AIR COMPRESSOR NO.2	212
POWER HOUSE 1	JOY-3	AIR COMPRESSOR NO.3	212
POWER HOUSE 1	TOSI-5	TOSI BOILER NO. 5	212
POWER HOUSE 1	TOSI-6	TOSI BOILER NO. 6	212
POWER HOUSE 1	TOSI-7	TOSI BOILER NO. 7	212
POWER HOUSE 1	MHI-14	MITSUBISHI BOILER NO. 14	212
POWER HOUSE 1	MHI-15	MITSUBISHI BOILER NO. 15	212
BUILDINGS AND AREAS		LUCC BUILDING	212
BUILDINGS AND AREAS		PRIMARY SEPARATOR	212
BUILDINGS AND AREAS		POWER HOUSE NO. 1	212
UPPER FIELD	TK-910	FUEL OIL	212
UPPER FIELD	TK-911	DIESEL	212
UPPER FIELD	TK-917	GASOIL	212
POWER HOUSE 1	TK-23	BOILER FEED WATER	212
POWER HOUSE 1	TK-1006	BOILER FEED WATER	212
POWER HOUSE 1	TK-400	BOILER FEED WATER	212
DISMANTLING COST			Medium Cost 200 - 450 MM USD

REFINERY AREA	UNIT NO.	DESCRIPTION	SITE PLAN
NORTH AREA COMPLEX	CSAR	CRUDE UNIT NO. 5	202-2
NORTH AREA COMPLEX	CEAR	CRUDE UNIT NO. 6	202-2
NORTH AREA COMPLEX	CFAR	CRUDE UNIT NO. 7	202-2
NORTH AREA COMPLEX	SGAR	SATURATED GAS PLANT	202-2
NORTH AREA COMPLEX	VBAR	VISBREAKER UNIT	202-2
NORTH AREA COMPLEX	LCAR	LOW GAS COMPRESSION	202-2
NORTH AREA COMPLEX	DMAR	DEMULSIFIER	202-2
NORTH AREA COMPLEX	MAAR	BUTANE MEROX UNIT	202-2
NORTH AREA COMPLEX	TUAR	FUELS	202-2
NORTH AREA COMPLEX		NITROGEN FACILITY	202-2
SOUTH AREA COMPLEX	D1AR	DISTILLATE HDS	202-2
SOUTH AREA COMPLEX	D2AR	HEAVY VACUUM GAS OIL HDS	202-2
SOUTH AREA COMPLEX	D3AR	HEAVY VACUUM GAS OIL HDS	202-2
SOUTH AREA COMPLEX	GVAR	GAS OIL HYDROTINER UNIT	202-2
SOUTH AREA COMPLEX	V3AR	VACUUM PRESTILL UNIT NO. 3	202-2
SOUTH AREA COMPLEX	FS1AR	FUEL GAS SCRUBBING NO.1	202-2
SOUTH AREA COMPLEX	FS2AR	FUEL GAS SCRUBBING NO.2	202-2
SOUTH AREA COMPLEX	SF1AR	EAST FLARE	202-2
SOUTH AREA COMPLEX	N1AR	HDS PURGE GAS RECOVERY	202-2
SOUTH AREA COMPLEX	N2AR	NAPHTHA HANDLING	202-2
SOUTH AREA COMPLEX	S2-3AR	SULFUR UNITS NO.2, NO.3	202-2
SOUTH AREA COMPLEX	S4AR	SULFUR UNIT NO. 4	202-2
SOUTH AREA COMPLEX	S5AR	SULFUR HANDLING UNIT NO.1	202-2
SOUTH AREA COMPLEX	S6AR	SULFUR HANDLING UNIT NO.2	202-2
SOUTH AREA COMPLEX	M1AR	AMINE UNIT NO. 1	202-2
SOUTH AREA COMPLEX	M2AR	AMINE UNIT NO. 2	202-2
SOUTH AREA COMPLEX	M3AR	AMINE UNIT NO. 3	202-2
SOUTH AREA COMPLEX	SW1-2AR	SOUR WATER STRIPPER UNITS NO.1 & NO.2	202-2
SOUTH AREA COMPLEX	SW3AR	SOUR WATER STRIPPER UNITS NO.3	202-2
SOUTH AREA COMPLEX	PSAR	PRESSURE SWING ABSORBER	202-2
SOUTH AREA COMPLEX	P1AR	HDS FUEL SYSTEM	202-2
SOUTH AREA COMPLEX	CRAR	(UNIT 39) CONDENSATE	202-2
POWER HOUSE 1	PB-1	PACKAGE BOILER NO. 1	202-2
POWER HOUSE 1	PB-2	PACKAGE BOILER NO. 2	202-2
POWER HOUSE 1	PB-3	PACKAGE BOILER NO. 3	202-2
POWER HOUSE 1	PB-4	PACKAGE BOILER NO. 4	202-2
BUILDINGS AND AREAS		LABORATORY BUILDING	202-2
DISMANTLING COST			High Cost 450 - 600 MM USD

REFINERY AREA	UNIT NO.	DESCRIPTION	SITE PLAN
SOUTH AREA COMPLEX	SF2AR	WEST FLARE	202-1
SOUTH AREA COMPLEX	DC1AR	DELAYED COKER #1	202-1
SOUTH AREA COMPLEX	DC2AR	DELAYED COKER #2	202-1
SOUTH AREA COMPLEX	SF3AR	SOUTH COKEY FLARE	202-1
SOUTH AREA COMPLEX	CHAR	COKE HANDLING (EXCLUDING COKE BARN)	202-1
POWER HOUSE 2	TG-1	TURBO GENERATOR NO. 1	202-1
POWER HOUSE 2	TG-2	TURBO GENERATOR NO. 2	202-1
POWER HOUSE 2	COOP-4	AIR COMPRESSOR NO.4	202-1
POWER HOUSE 2	COOP-5	AIR COMPRESSOR NO.5	202-1
POWER HOUSE 3	TG-11	TURBO GENERATOR NO. 11	202-1
BUILDINGS AND AREAS		POWER HOUSE NO. 3	202-1
BUILDINGS AND AREAS		POWER HOUSE NO. 2	202-1
DISMANTLING COST			Medium Cost 200 - 450 MM USD

LEGEND OF INFRASTRUCTURE TO BE REMOVED

- ROADS
- SECONDARY ROADS
- SLOPE
- HIGH TENSION LINE/ TRANSFORMERS
- TANK FOUNDATIONS
- FIRE SYSTEM
- STACKS
- FLARE
- S.S. SUBSTATION
- P.H. PUMP HOUSE
- U.B. UTILITY BUILDING
- F.W. FIRE WATER
- L.S. LUNCH SHELTER
- TANKS

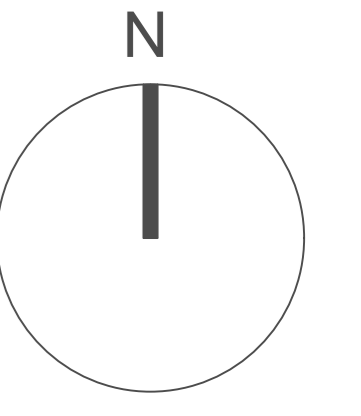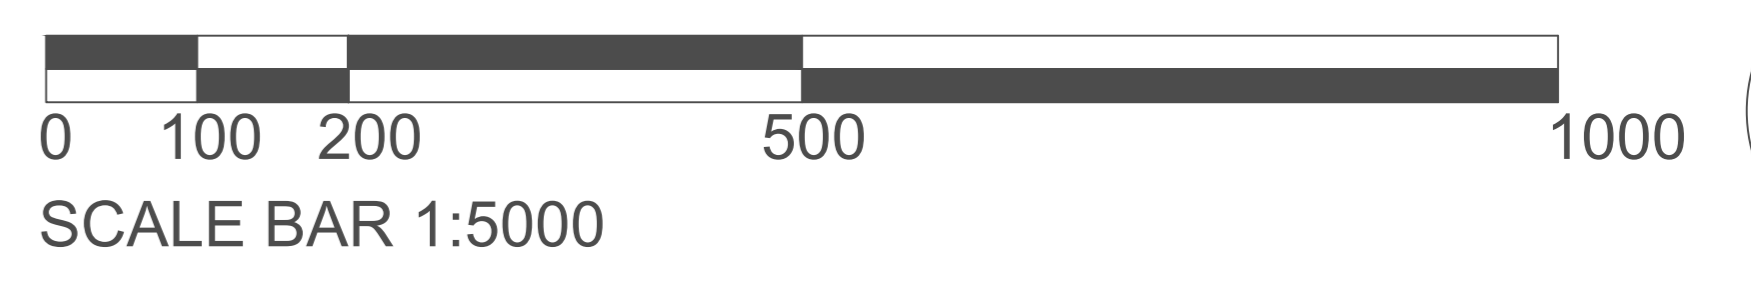

DRAWN BY: ROCIÓ MARTINEZ	SCALE : AS SHOWN	REVISION	DATE / BY
CHECKED BY: MEIER MADURO	DIMENSIONS : MM	1	JUL-31-2020
APPROVED BY:	FORMAT :	2	
		3	

ARUBA SAN NICOLAS
DISMANTLING DIAGRAM